


PLAN-UPPER LEVEL (EL.=125.0')
SCALE: 1/4" = 1'-0"

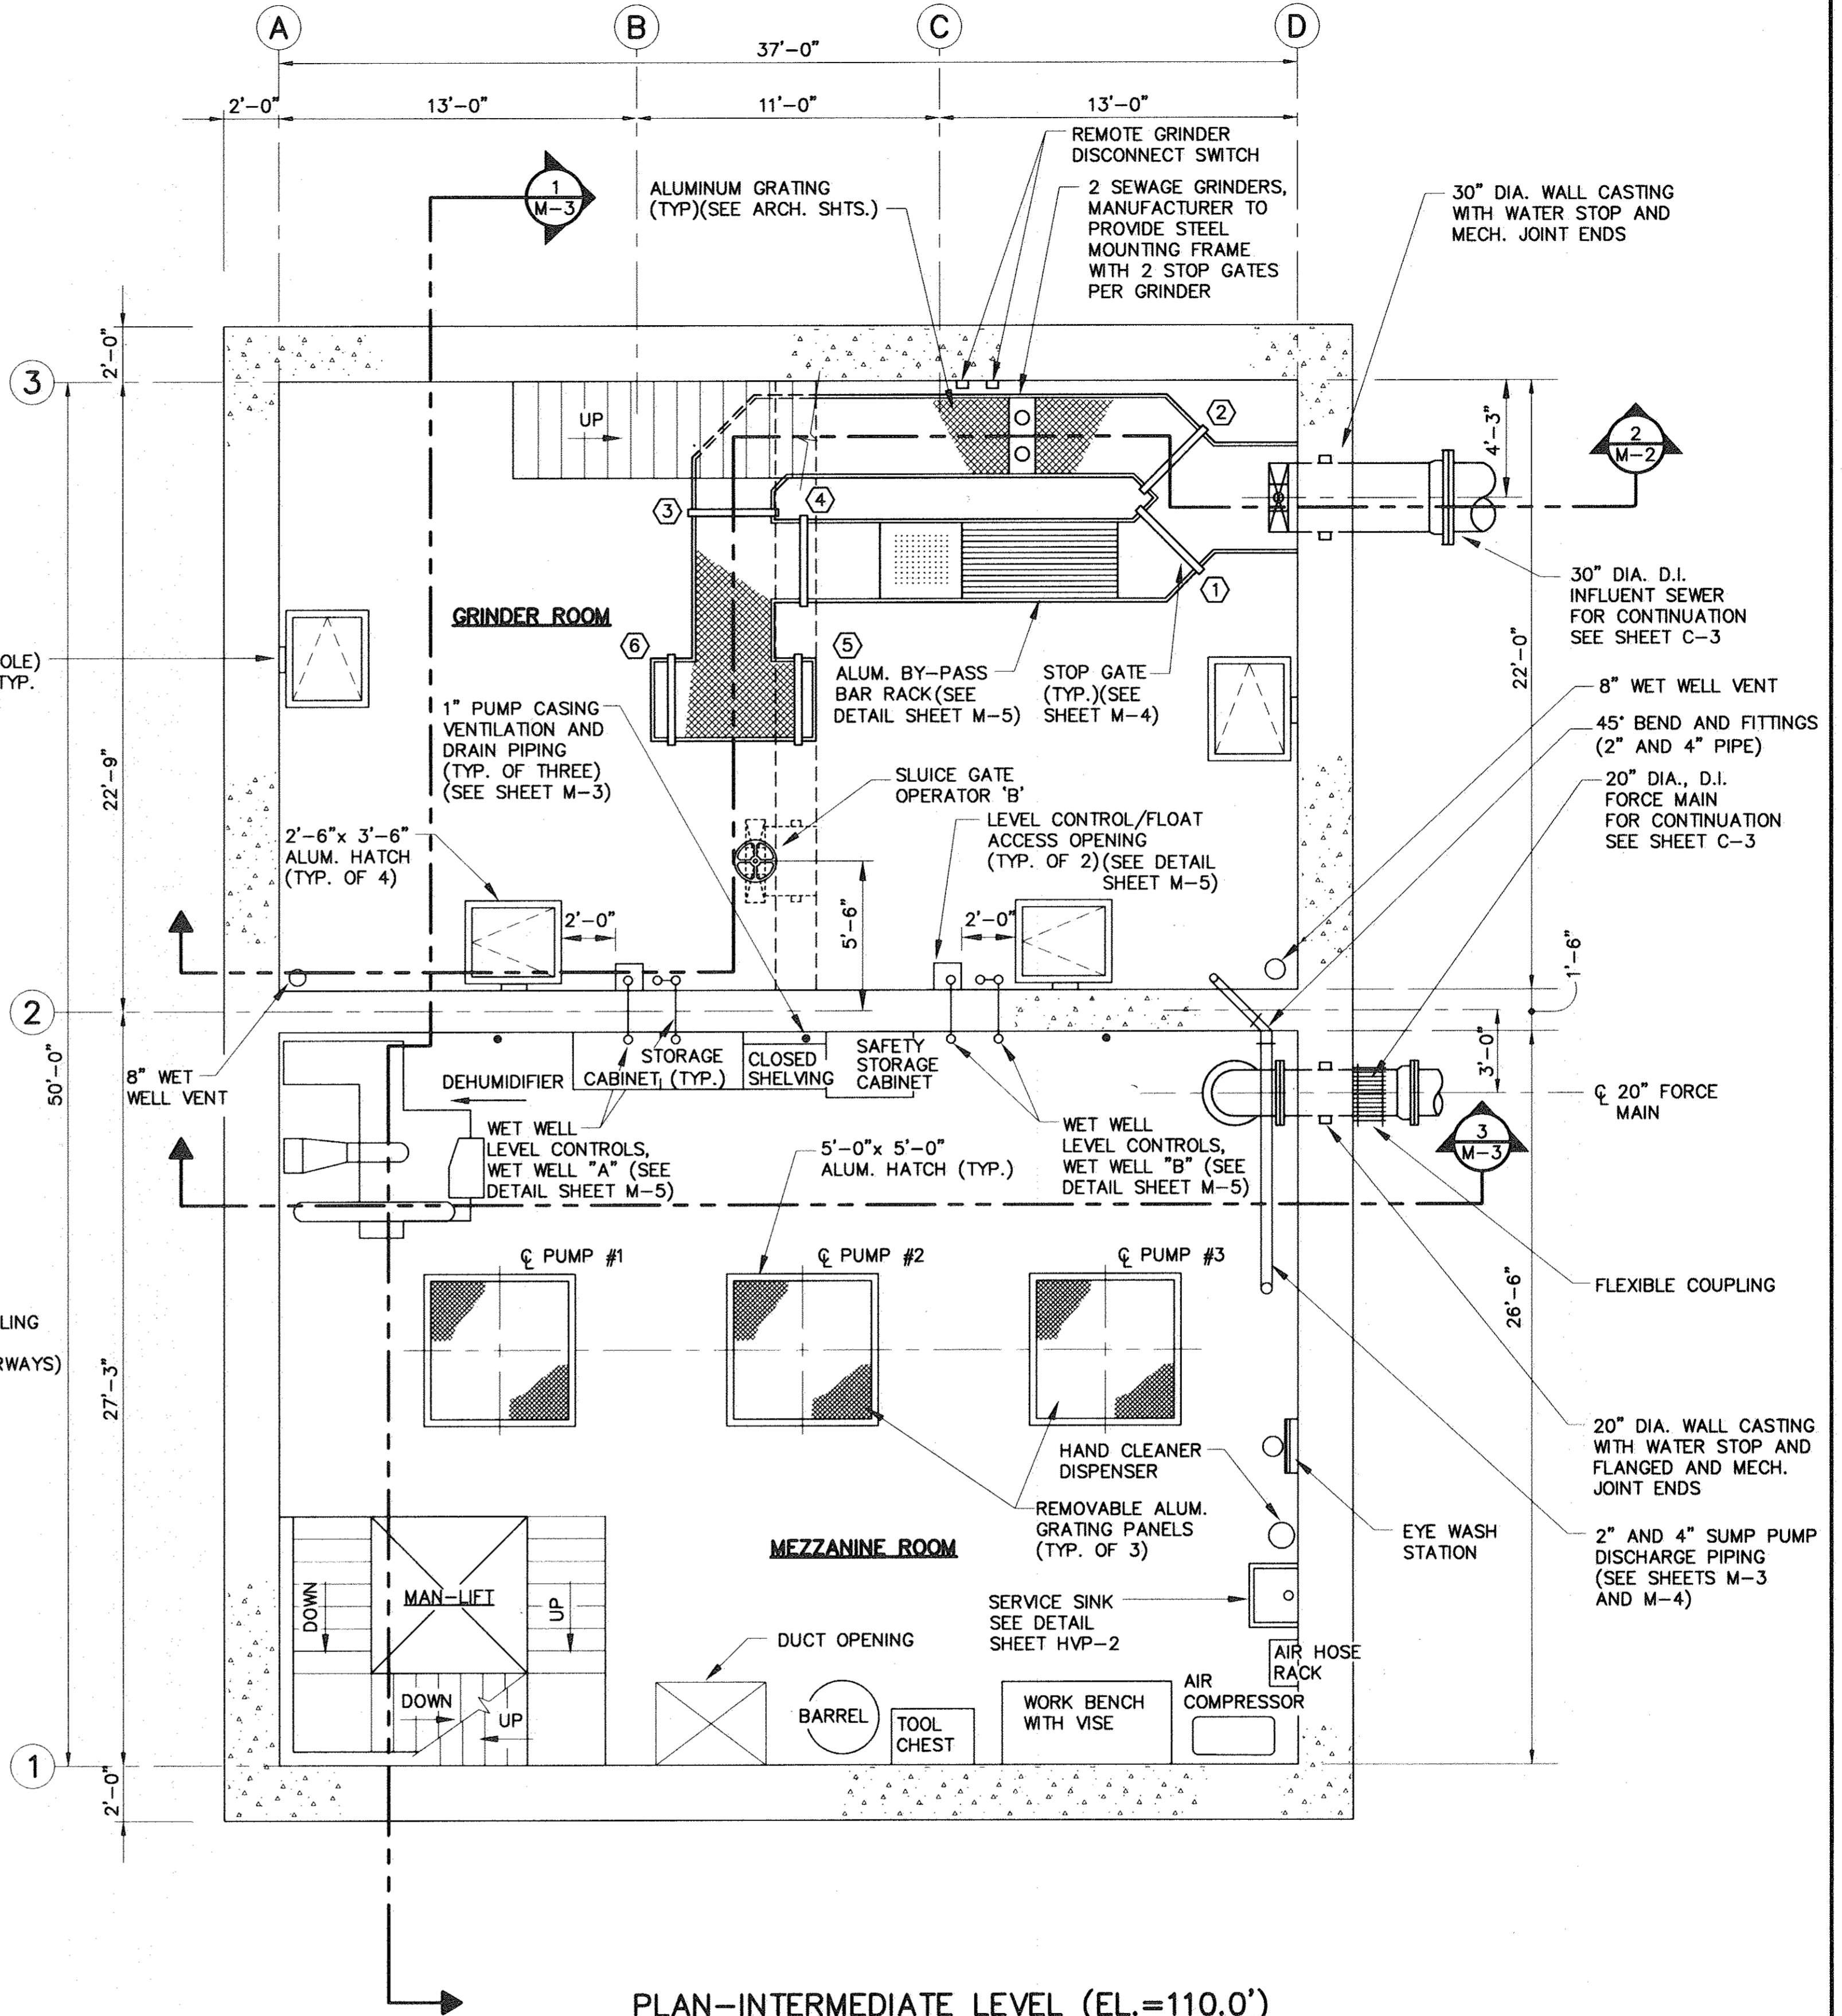

PLAN-INTERMEDIATE LEVEL (EL.=110.0')
SCALE: 1/4" = 1'-0"

Weston & Sampson
ENGINEERS, P.C.

Five Centennial Drive, Peabody, MA 01960-7985

REGISTERED PROFESSIONAL ENGINEER

Peter M. Schooler

3/15/92 DATE

No.	Date	Dr. By	Ck. By	App. By	Description
3	5/95	M.R.K.	M.L.M.	F.W.Y.	REVISED FOR RECORD DRAWING
2	3/92	R.W.S.	M.L.M.	P.M.S.	GENERAL REVISIONS
1	7/91	S.G.I.	M.L.M.	P.M.S.	GENERAL REVISIONS

TOWN OF LEXINGTON, MASSACHUSETTS
DEPARTMENT OF PUBLIC WORKS
NORTH LEXINGTON MAIN PUMPING STATION

UPPER AND INTERMEDIATE LEVEL FLOOR PLANS

FILE NO. 69-39	SCALE NOTED	CONTRACT 92-1	JOB NO. 9065	APP. BY P.M.S.
CADD NO. RNL-M-1	DR. BY S.M.L.	CK. BY M.L.M.	APP. BY P.M.S.	

M-1

RECORD DRAWING

SHEET 26 OF 42